



UPDATED: Thursday, November 14, 2013 2:35:46 PM BY: Manual

PRINTED: Thursday, November 14, 2013 2:35:42 PM DWG NAME: H:\PROJECTS New NDS\Design Drafting\General\DFR\PF\DFR-10-PR-PF-0003 Rev 0A.dwg

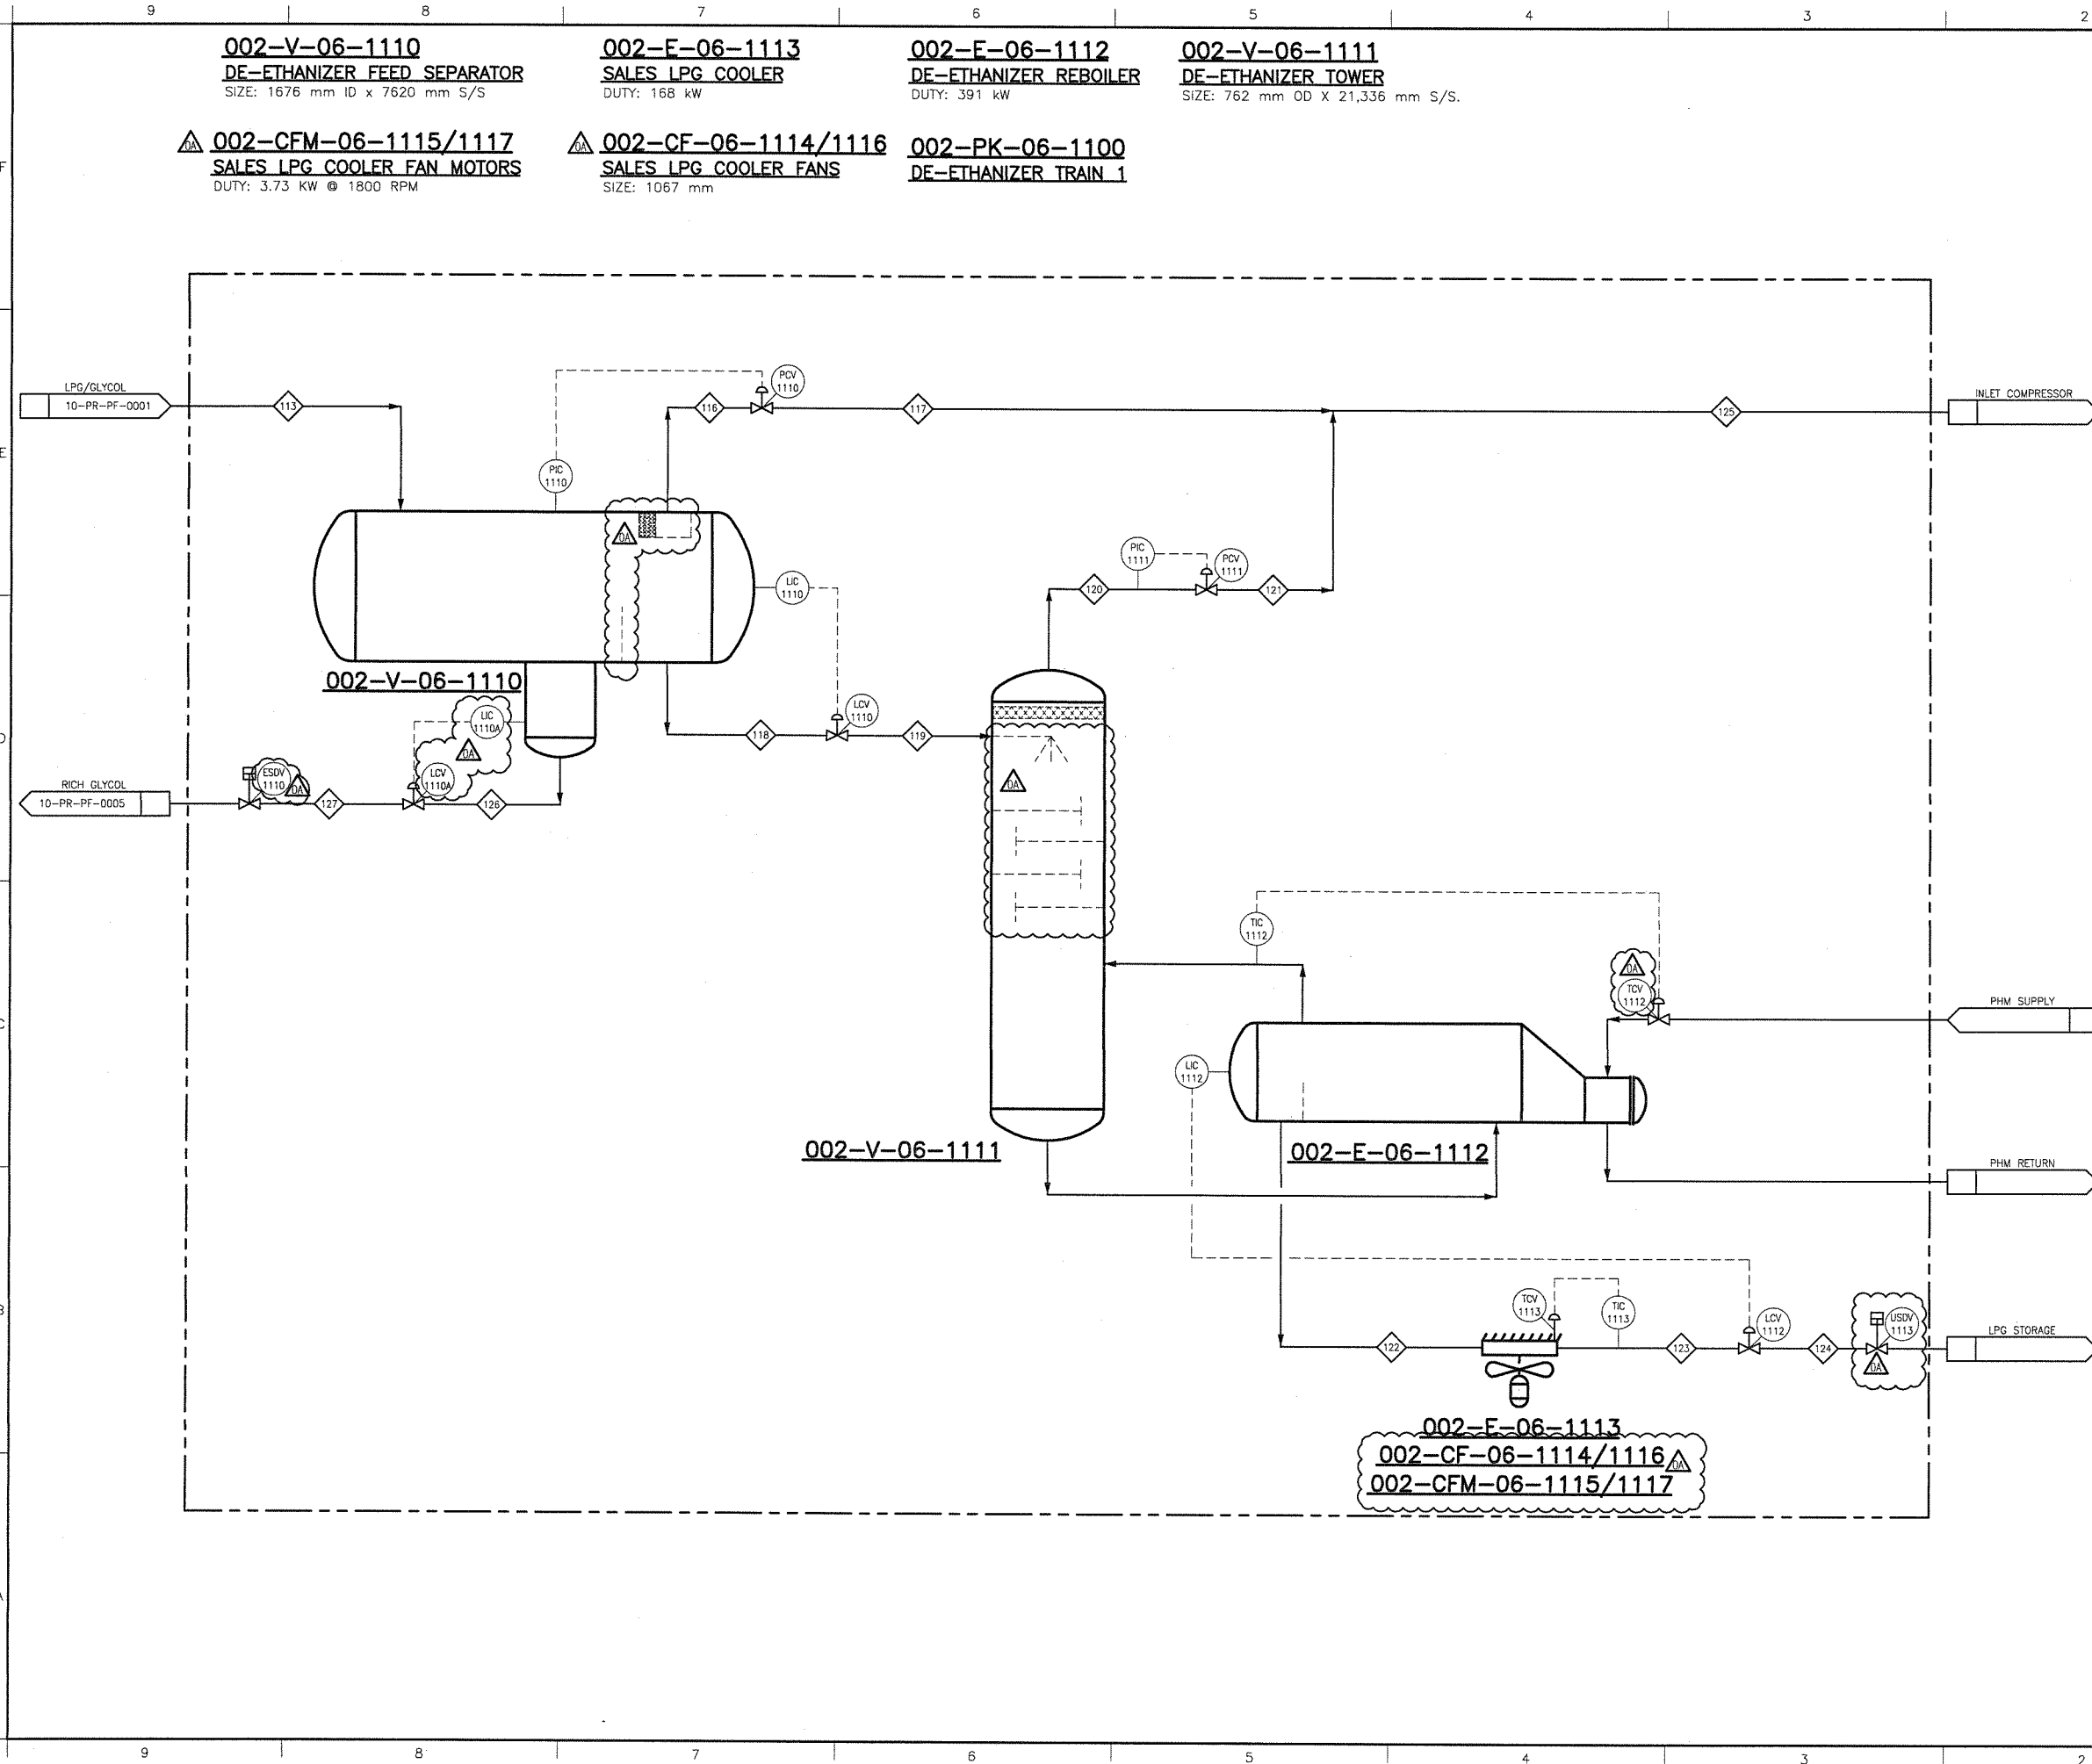

GENERAL NOTES:

**CONTROLLED RELEASE**  
TDE  
NOV 15 2013  
SIGNED: *CM*

OA	REVISED AS MARKED	NOV.14/13	—
O	RELEASED FOR FABRICATION	FEB.8/13	MFF
NO.	REVISION	DATE	BY
ELECTRICAL	I & V:	CONTROLS	PROCESS
PROJECT NAME:		FERRIER CENTRAL PROCESSING FACILITY	
CLIENT:			
DEVON CANADA c/o WORLEY PARSONS			
DOCUMENT NAME:			
DE—ETHANIZER PROCESS FLOW DIAGRAM			
 THERMO DESIGN ENGINEERING LTD. OIL & GAS PRODUCTION EQUIPMENT DESIGN • FABRICATION • INSTALLATION EDMONTON, ALBERTA, CANADA APECSA PERMIT NUMBER: P2800		P. ENG. STAMP:	
THIS DRAWING IS THE CONFIDENTIAL PROPERTY OF TDE AND IS ISSUED ON THE UNDERSTANDING THAT NOTHING IS TO BE COPIED OR COMMUNICATED TO A THIRD PARTY WITHOUT THE WRITTEN AUTHORIZATION OF TDE.			
TDE JOB NUMBER:		12-118	
DOCUMENT NUMBER:		DFR-10-PR-PF-0003	
ITEM:		SHEET:	REV:
. .		. .	0A