



UPDATED: Thursday, November 14, 2013 2:42:06 PM BY: Manual

PRINTED: Thursday, November 14, 2013 3:20:37 PM DWG NAME: H:\PROJECTS New MDS\Design Drafting\General\DFR\DFR-10-PR-PF-0004 Rev 04.dwg

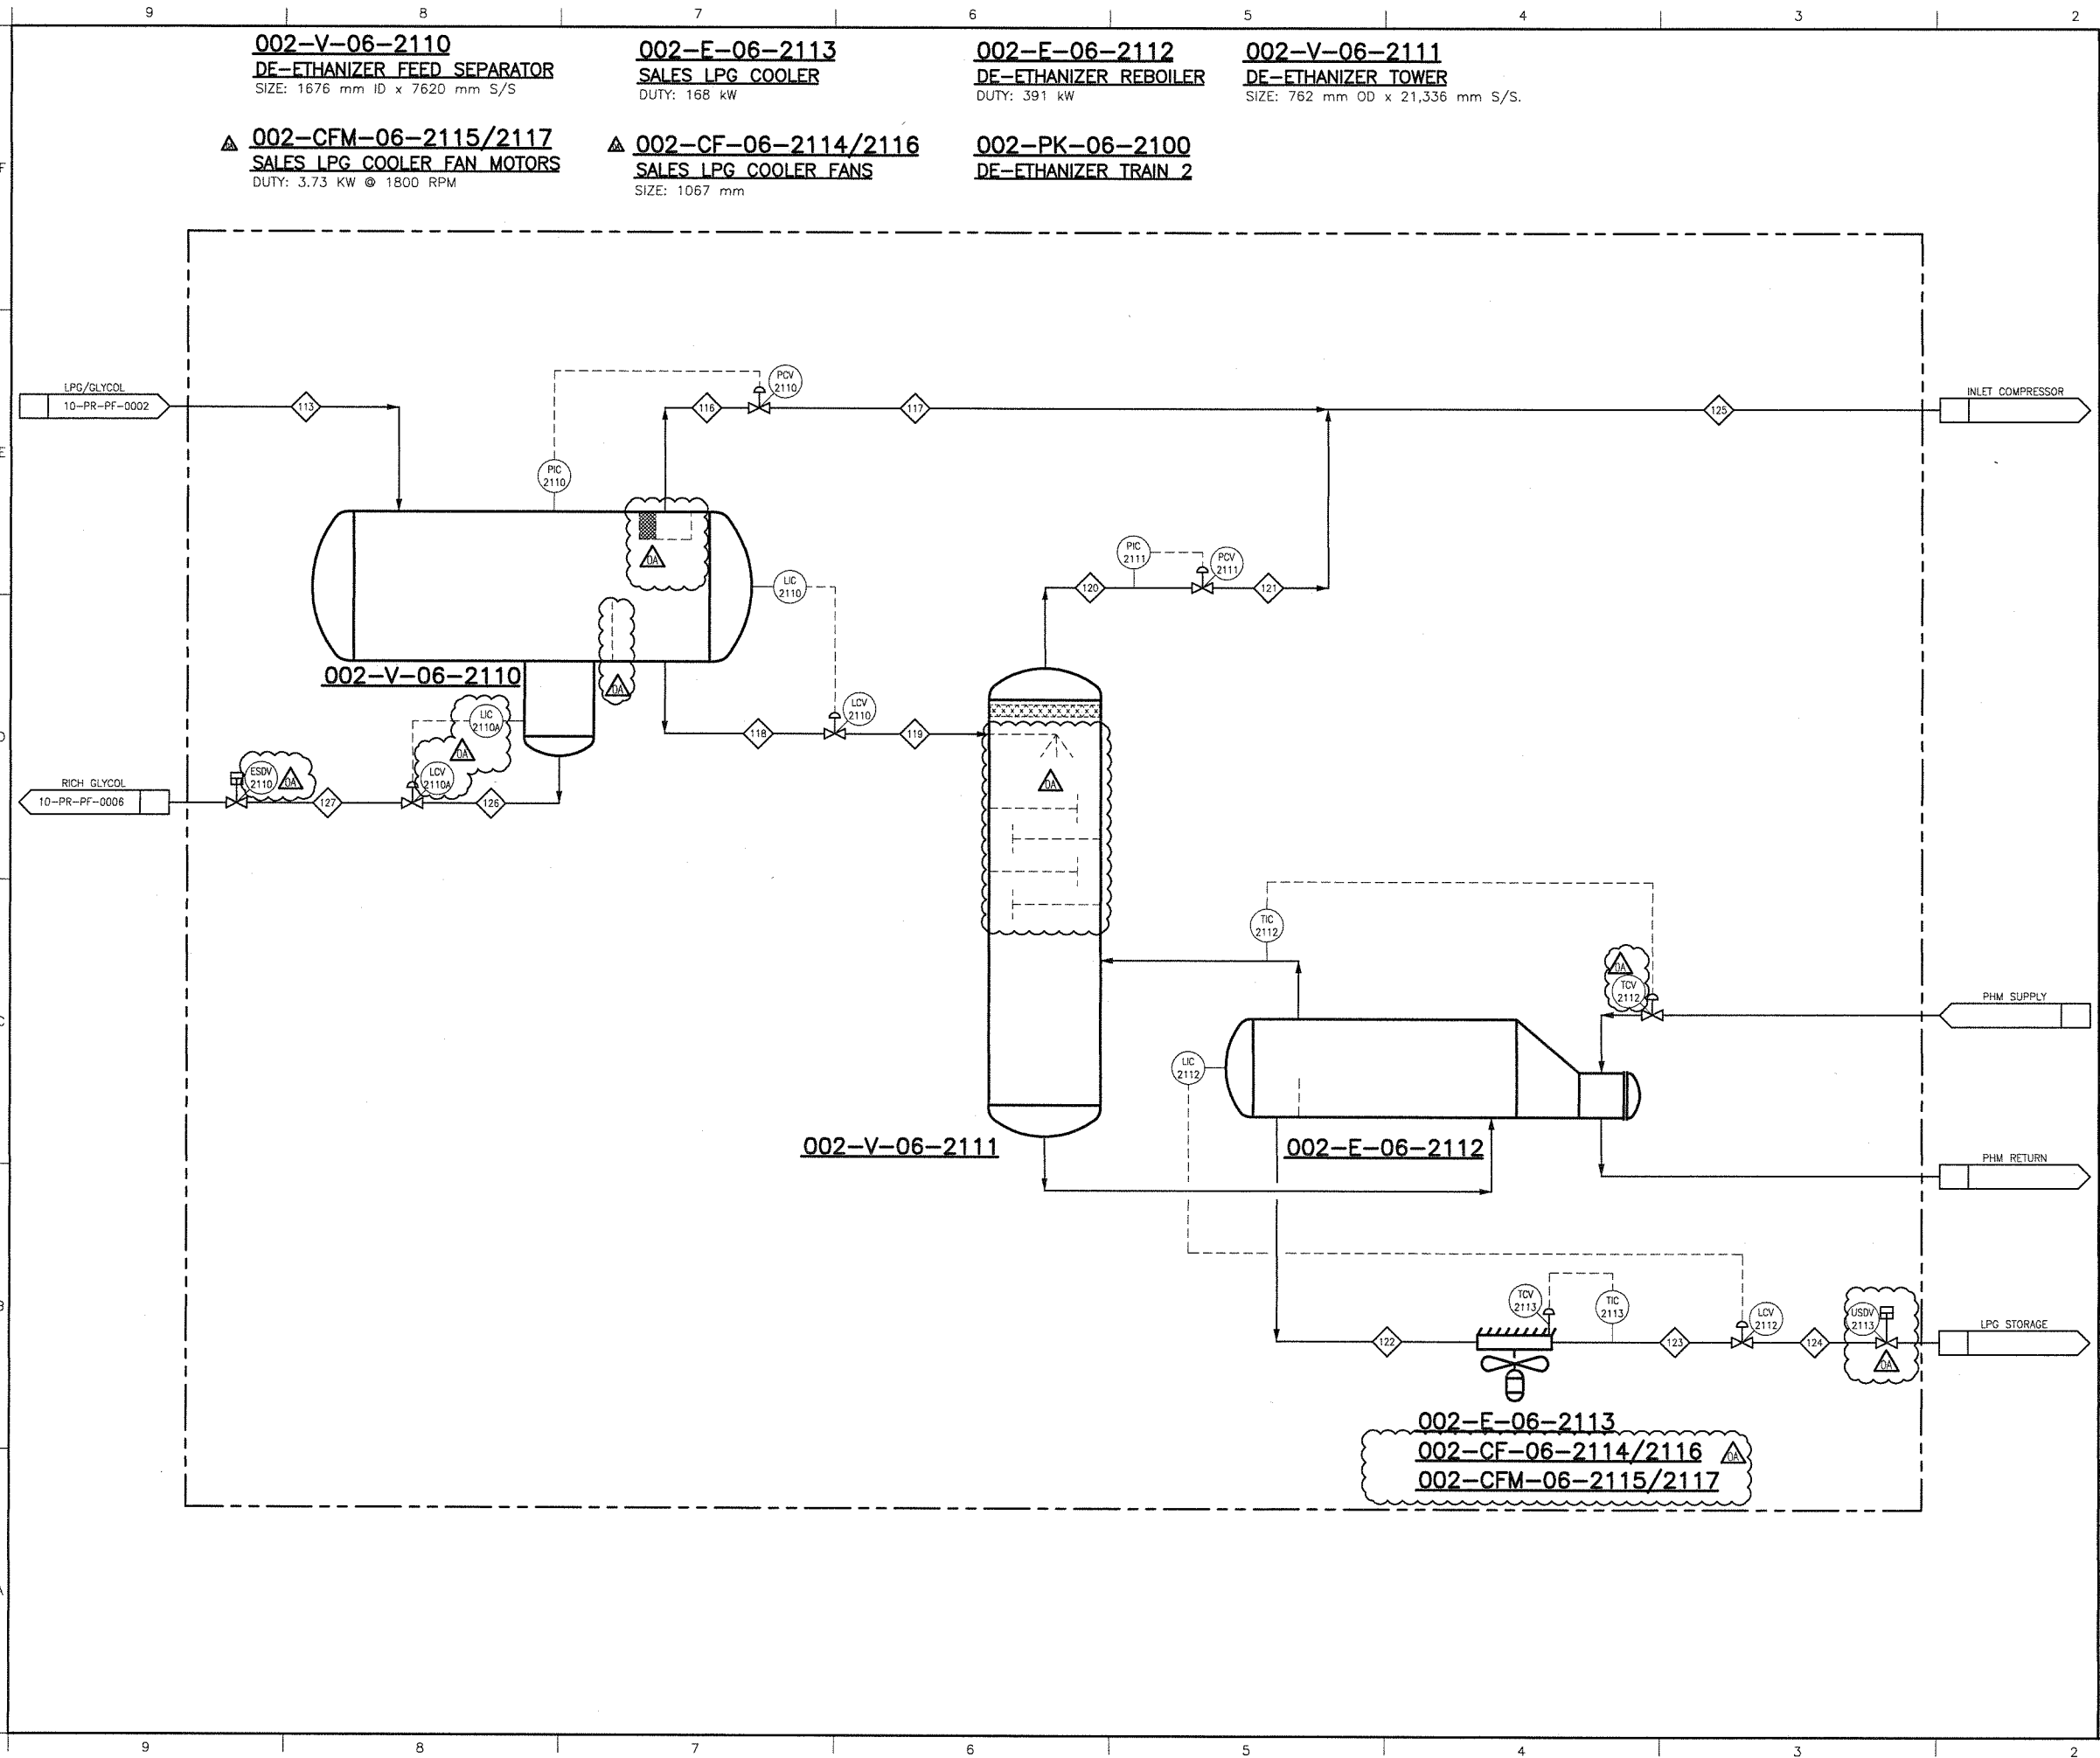

GENERAL NOTES:

CONTROLLED RELEASE
NOV 15 2013
SIGNED: *OK*

NO.	REVISION	DATE	BY
0A	REVISED AS MARKED	NOV.14/13	-
0	RELEASED FOR FABRICATION	FEB.8/13	MFF
ELECTRICAL:	I & V:	CONTROLS:	PROCESS:
PROJECT NAME: FERRIER CENTRAL PROCESSING FACILITY			
CLIENT: DEVON CANADA c/o WORLEY PARSONS			
DOCUMENT NAME: DE-ETHANIZER PROCESS FLOW DIAGRAM			
 THERMO DESIGN ENGINEERING LTD. OIL & GAS PRODUCTION EQUIPMENT DESIGN • FABRICATION • INSTALLATION EDMONTON, ALBERTA, CANADA APEGGA PERMIT NUMBER: P2800		P. ENG. STAMP:	
THIS DRAWING IS THE CONFIDENTIAL PROPERTY OF TDE AND IS ISSUED ON THE UNDERSTANDING THAT NOTHING IS TO BE COPIED OR COMMUNICATED TO A THIRD PARTY WITHOUT THE WRITTEN AUTHORIZATION OF TDE.			
TDE JOB NUMBER: 12-118			
DOCUMENT NUMBER: DFR-10-PR-PF-0004		ITEM:	SHEET: . REV: OA