



9 8 7 6 5 4 3 2 1

UPDATED: Wednesday, November 13, 2013 10:56:28 AM BY: Manual

PRINTED: Monday, January 20, 2014 9:17:13 AM DWG NAME: H:\PROJECTS New NDS Design Drafting\General\DFR\PI-51-PR-PI-0005 Rev 08.dwg

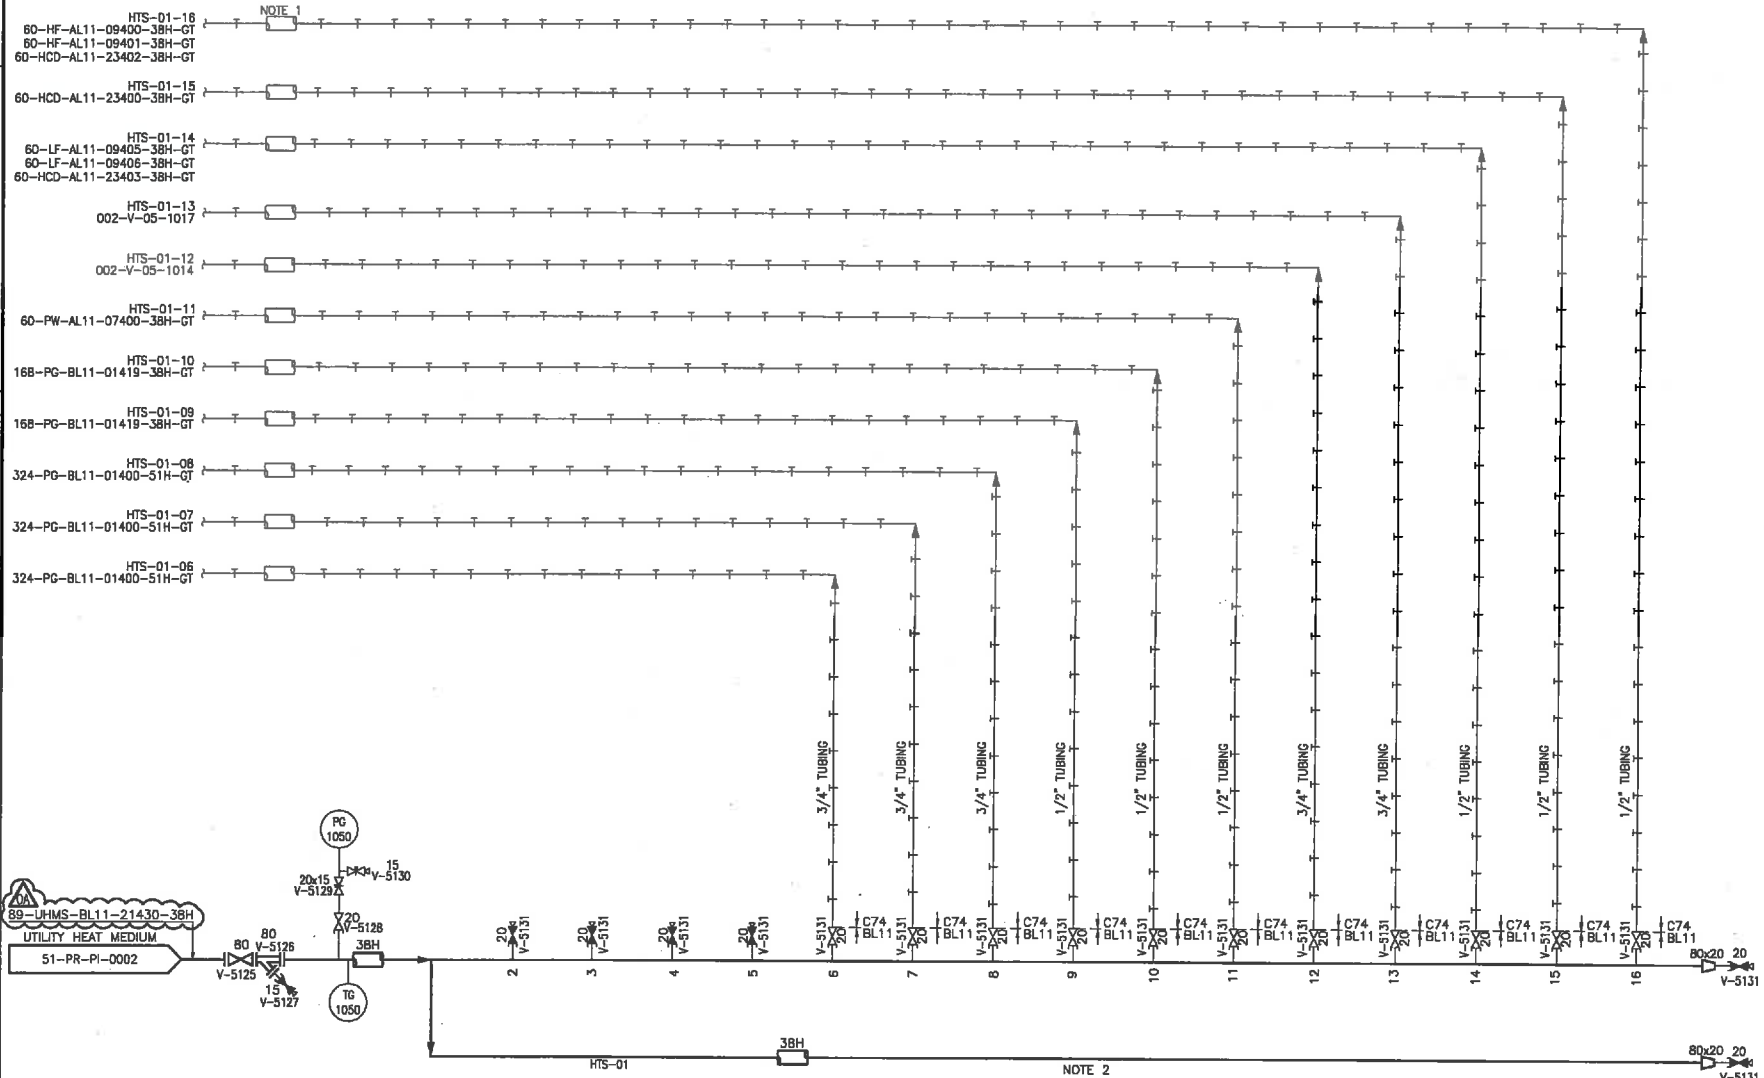

- GENERAL NOTES:**
1. PREINSULATED TUBING TO BE USED FOR ALL TRACER CIRCUITS.
 2. SECOND MANIFOLD LEG INCLUDED TO ACCOMMODATE FUTURE COMPRESSION TRAIN.

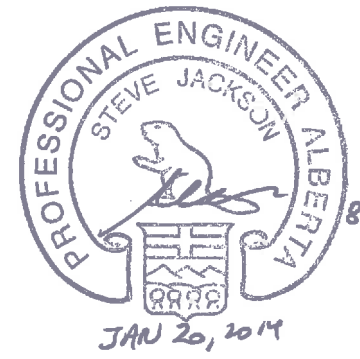

OB	REVISED AS MARKED	NOV.07/13	MFF
OA	REVISED AS MARKED	OCT.08/13	SSE
0	RELEASED FOR FABRICATION	SEP.24/13	SSE
NO.	REVISION	DATE	BY
ELECTRICAL:	1 & 10:	CONTROL:	PROCESS:
PROJECT NAME:			
FERRIER CENTRAL PROCESSING FACILITY			
CLIENT:			
DEVON CANADA c/o WORLEY PARSONS			
DOCUMENT NAME:			
HEAT TRACING SUPPLY MANIFOLD #1 PIPING AND INSTRUMENTATION DIAGRAM			
THERMO DESIGN ENGINEERING LTD.			
OIL & GAS PRODUCTION EQUIPMENT DESIGN • FABRICATION • INSTALLATION EDMONTON, ALBERTA, CANADA			
APPROXIMATE PROJECT NUMBER: P2800			
THIS DRAWING IS THE CONFIDENTIAL PROPERTY OF TDE AND IS LOANED TO THE USER UNDER THE CONDITION THAT IT IS TO BE KEPT IN CONFIDENCE AND NOT TO BE REPRODUCED OR USED FOR ANY OTHER PROJECT WITHOUT THE WRITTEN AUTHORIZATION OF TDE.			
TDE JOB NUMBER:			
12-118			
DOCUMENT NUMBER:			
DFR-51-PR-PI-0005			
ITEM:	SHEET:	REV:	OB