



PRINTED: Monday, January 20, 2014 9:17:16 AM DWG NAME: H:\PROJECTS New NOS\Design Drafting\General\DFR\PI-007 Rev 08.dwg
UPDATED: Wednesday, November 13, 2013 10:56:38 AM BY: Manual

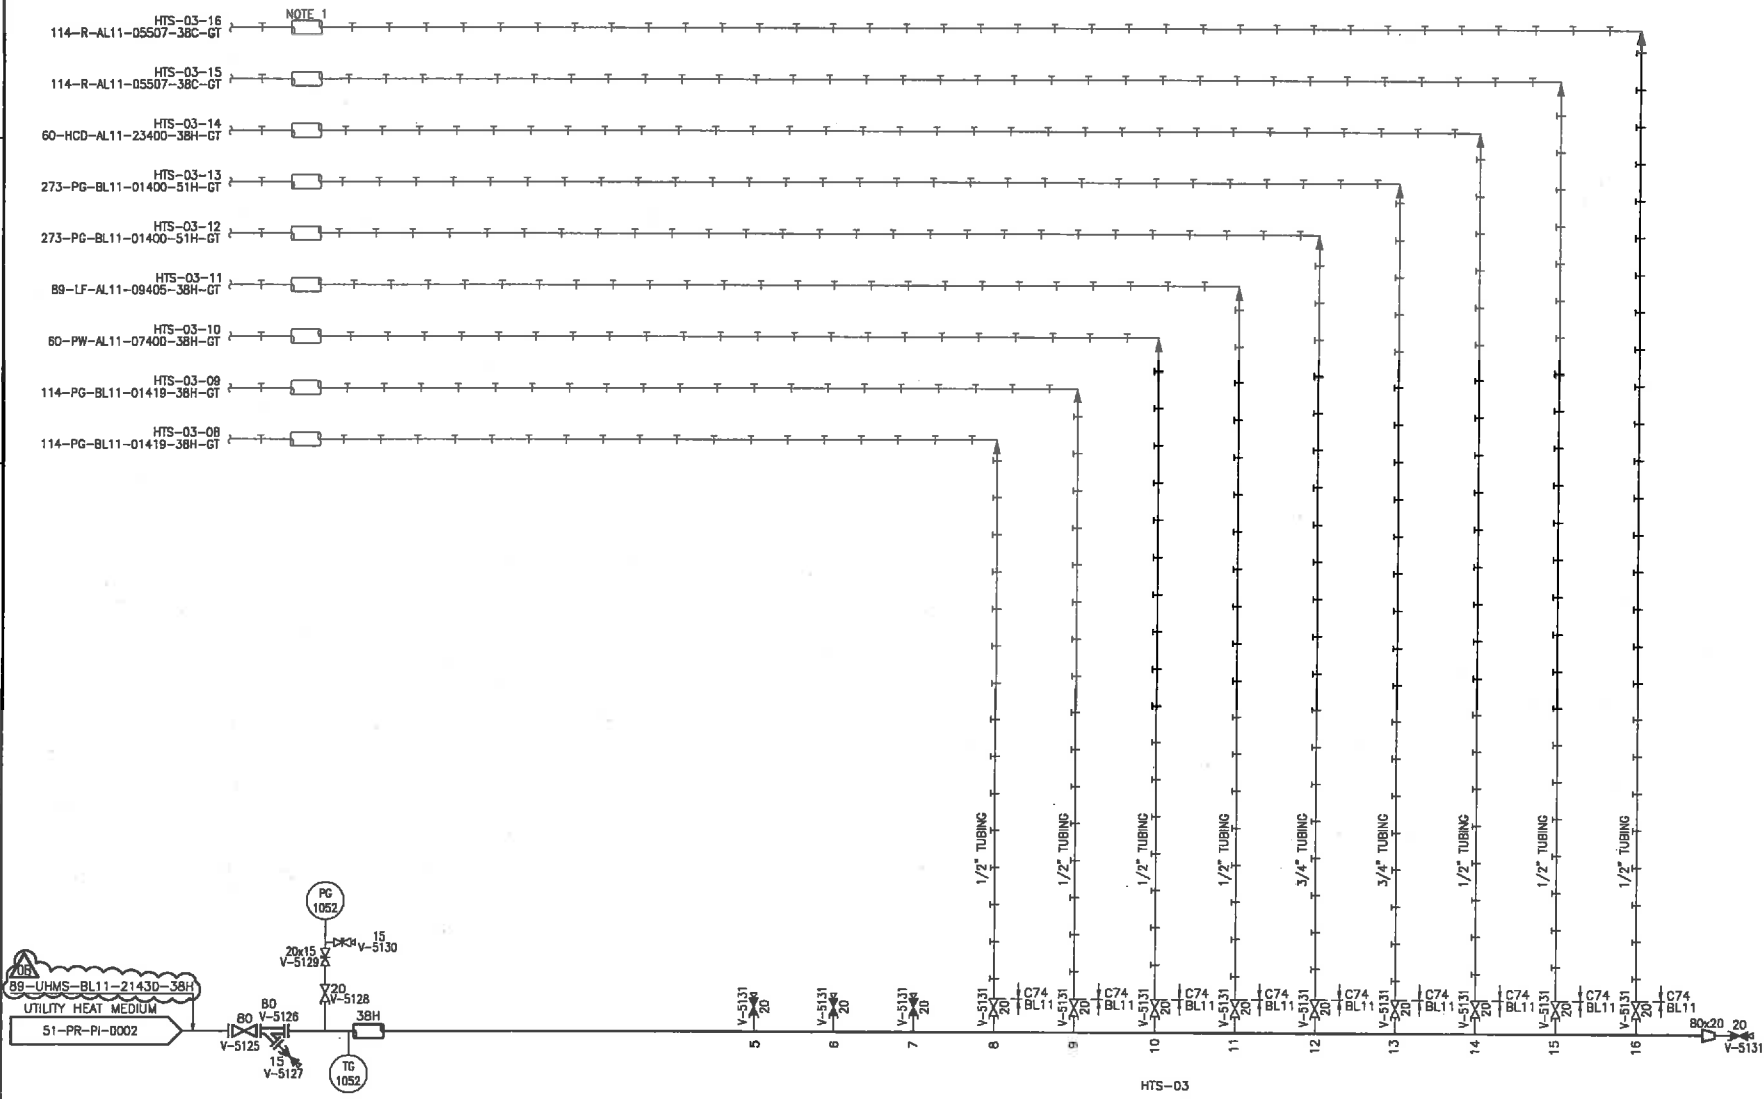

GENERAL NOTES:
1. PREINSULATED TUBING TO BE USED FOR ALL TRACER CIRCUITS.

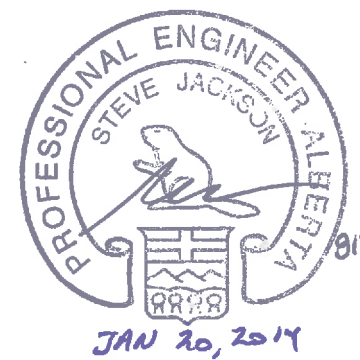

08	REVISED AS MARKED	NOV.07/13	MFF
0A	REVISED AS MARKED	OCT.08/13	SSE
0	RELEASED FOR FABRICATION	SEP.24/13	SSE
NO.	REVISION	DATE	BY
ELECTRICAL:	I & V:	CONTROLS:	PROCESS:
PROJECT NAME:			
FERRIER CENTRAL PROCESSING FACILITY			
CLIENT:			
DEVON CANADA c/o WORLEY PARSONS			
DOCUMENT NAME:			
HEAT TRACING SUPPLY MANIFOLD #3 PIPING AND INSTRUMENTATION DIAGRAM			
TDE DESIGN ENGINEERING LTD. OIL & GAS PRODUCTION EQUIPMENT DESIGN • FABRICATION • INSTALLATION EDMONTON, ALBERTA, CANADA APEGGA PERMIT NUMBER: P2800			
THE DRAWING IS THE CONFIDENTIAL PROPERTY OF TDE AND IS LOANED ON THE UNDERSTANDING THAT NOTHING IS TO BE COPIED OR COMMUNICATED TO A THIRD PARTY WITHOUT THE WRITTEN AUTHORIZATION OF TDE.			
TDE JOB NUMBER:			
12-118			
DOCUMENT NUMBER:			
DFR-51-PR-PI-0007			
ITEM	SHEET	REV	OB