


PRINTED: Monday, January 20, 2014 9:17:21 AM DWG NAME: H:\PROJECTS New NOS\Design Drafting\General\DFR\PI\PI-0011 Rev 08.dwg
UPDATED: Wednesday, November 13, 2013 10:58:20 AM BY: Manual

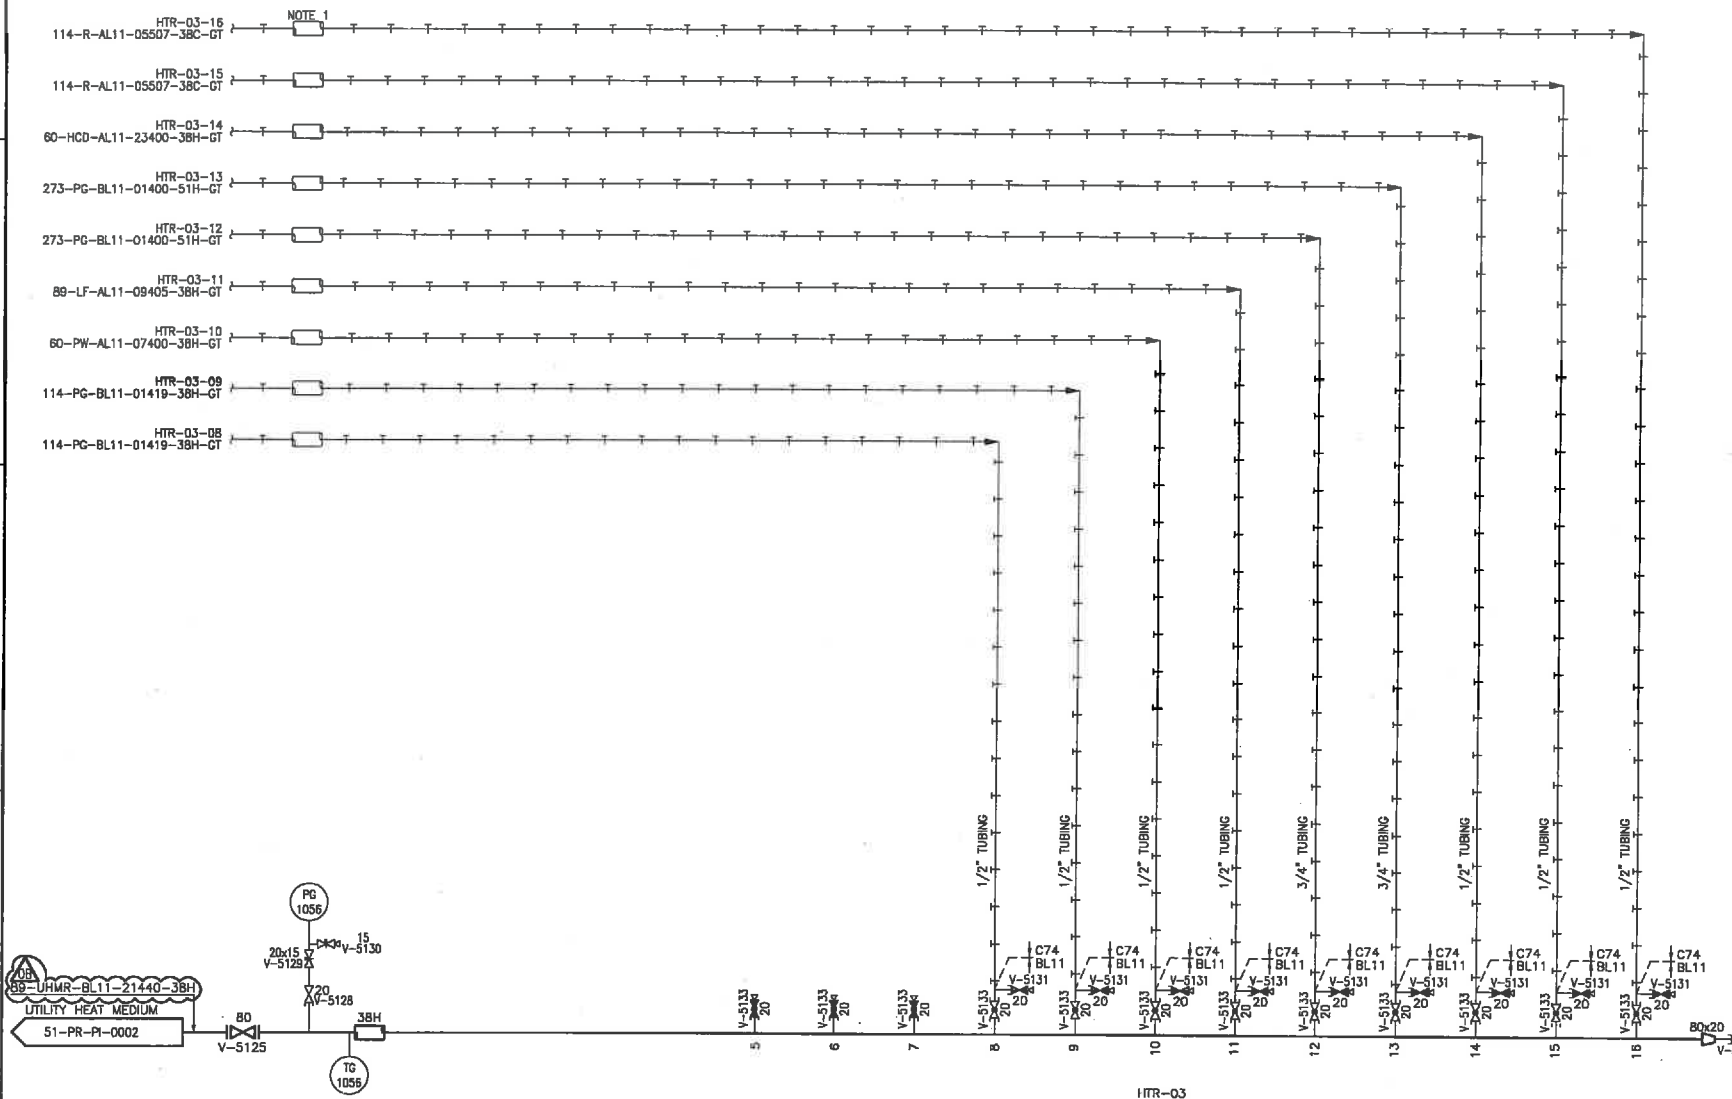

GENERAL NOTES:
1. PREINSULATED TUBING TO BE USED FOR ALL TRACER CIRCUITS.



OB	REVISED AS MARKED	NOV.07/13	MFF
OA	REVISED AS MARKED	OCT.08/13	SSE
D	RELEASED FOR FABRICATION	AUG.12/13	VV
NO.	REVISION	DATE	BY
ELECTRICAL:	I & V:	CONTROLS:	PROCESS:
PROJECT NAME:			
FERRIER CENTRAL PROCESSING FACILITY			
CLIENT:			
DEVON CANADA c/o WORLEY PARSONS			
DOCUMENT NAME:			
HEAT TRACING RETURN MANIFOLD #3 PIPING AND INSTRUMENTATION DIAGRAM			
THERMO DESIGN ENGINEERING LTD.			
OIL & GAS PRODUCTION EQUIPMENT DESIGN • FABRICATION • INSTALLATION EDMONTON, ALBERTA, CANADA			
APRADA PERMIT NUMBER: P2800			
THIS DRAWING IS THE CONFIDENTIAL PROPERTY OF THE A&P & IS TO BE KEPT IN THE A&P OFFICE. IT IS TO BE KEPT IN THE A&P OFFICE. IT IS TO BE KEPT IN THE A&P OFFICE.			
TDE JOB NUMBER:			
12-118			
DOCUMENT NUMBER:			
DFR-51-PR-PI-0011			
DATE:	SHEET:	REV:	OB