


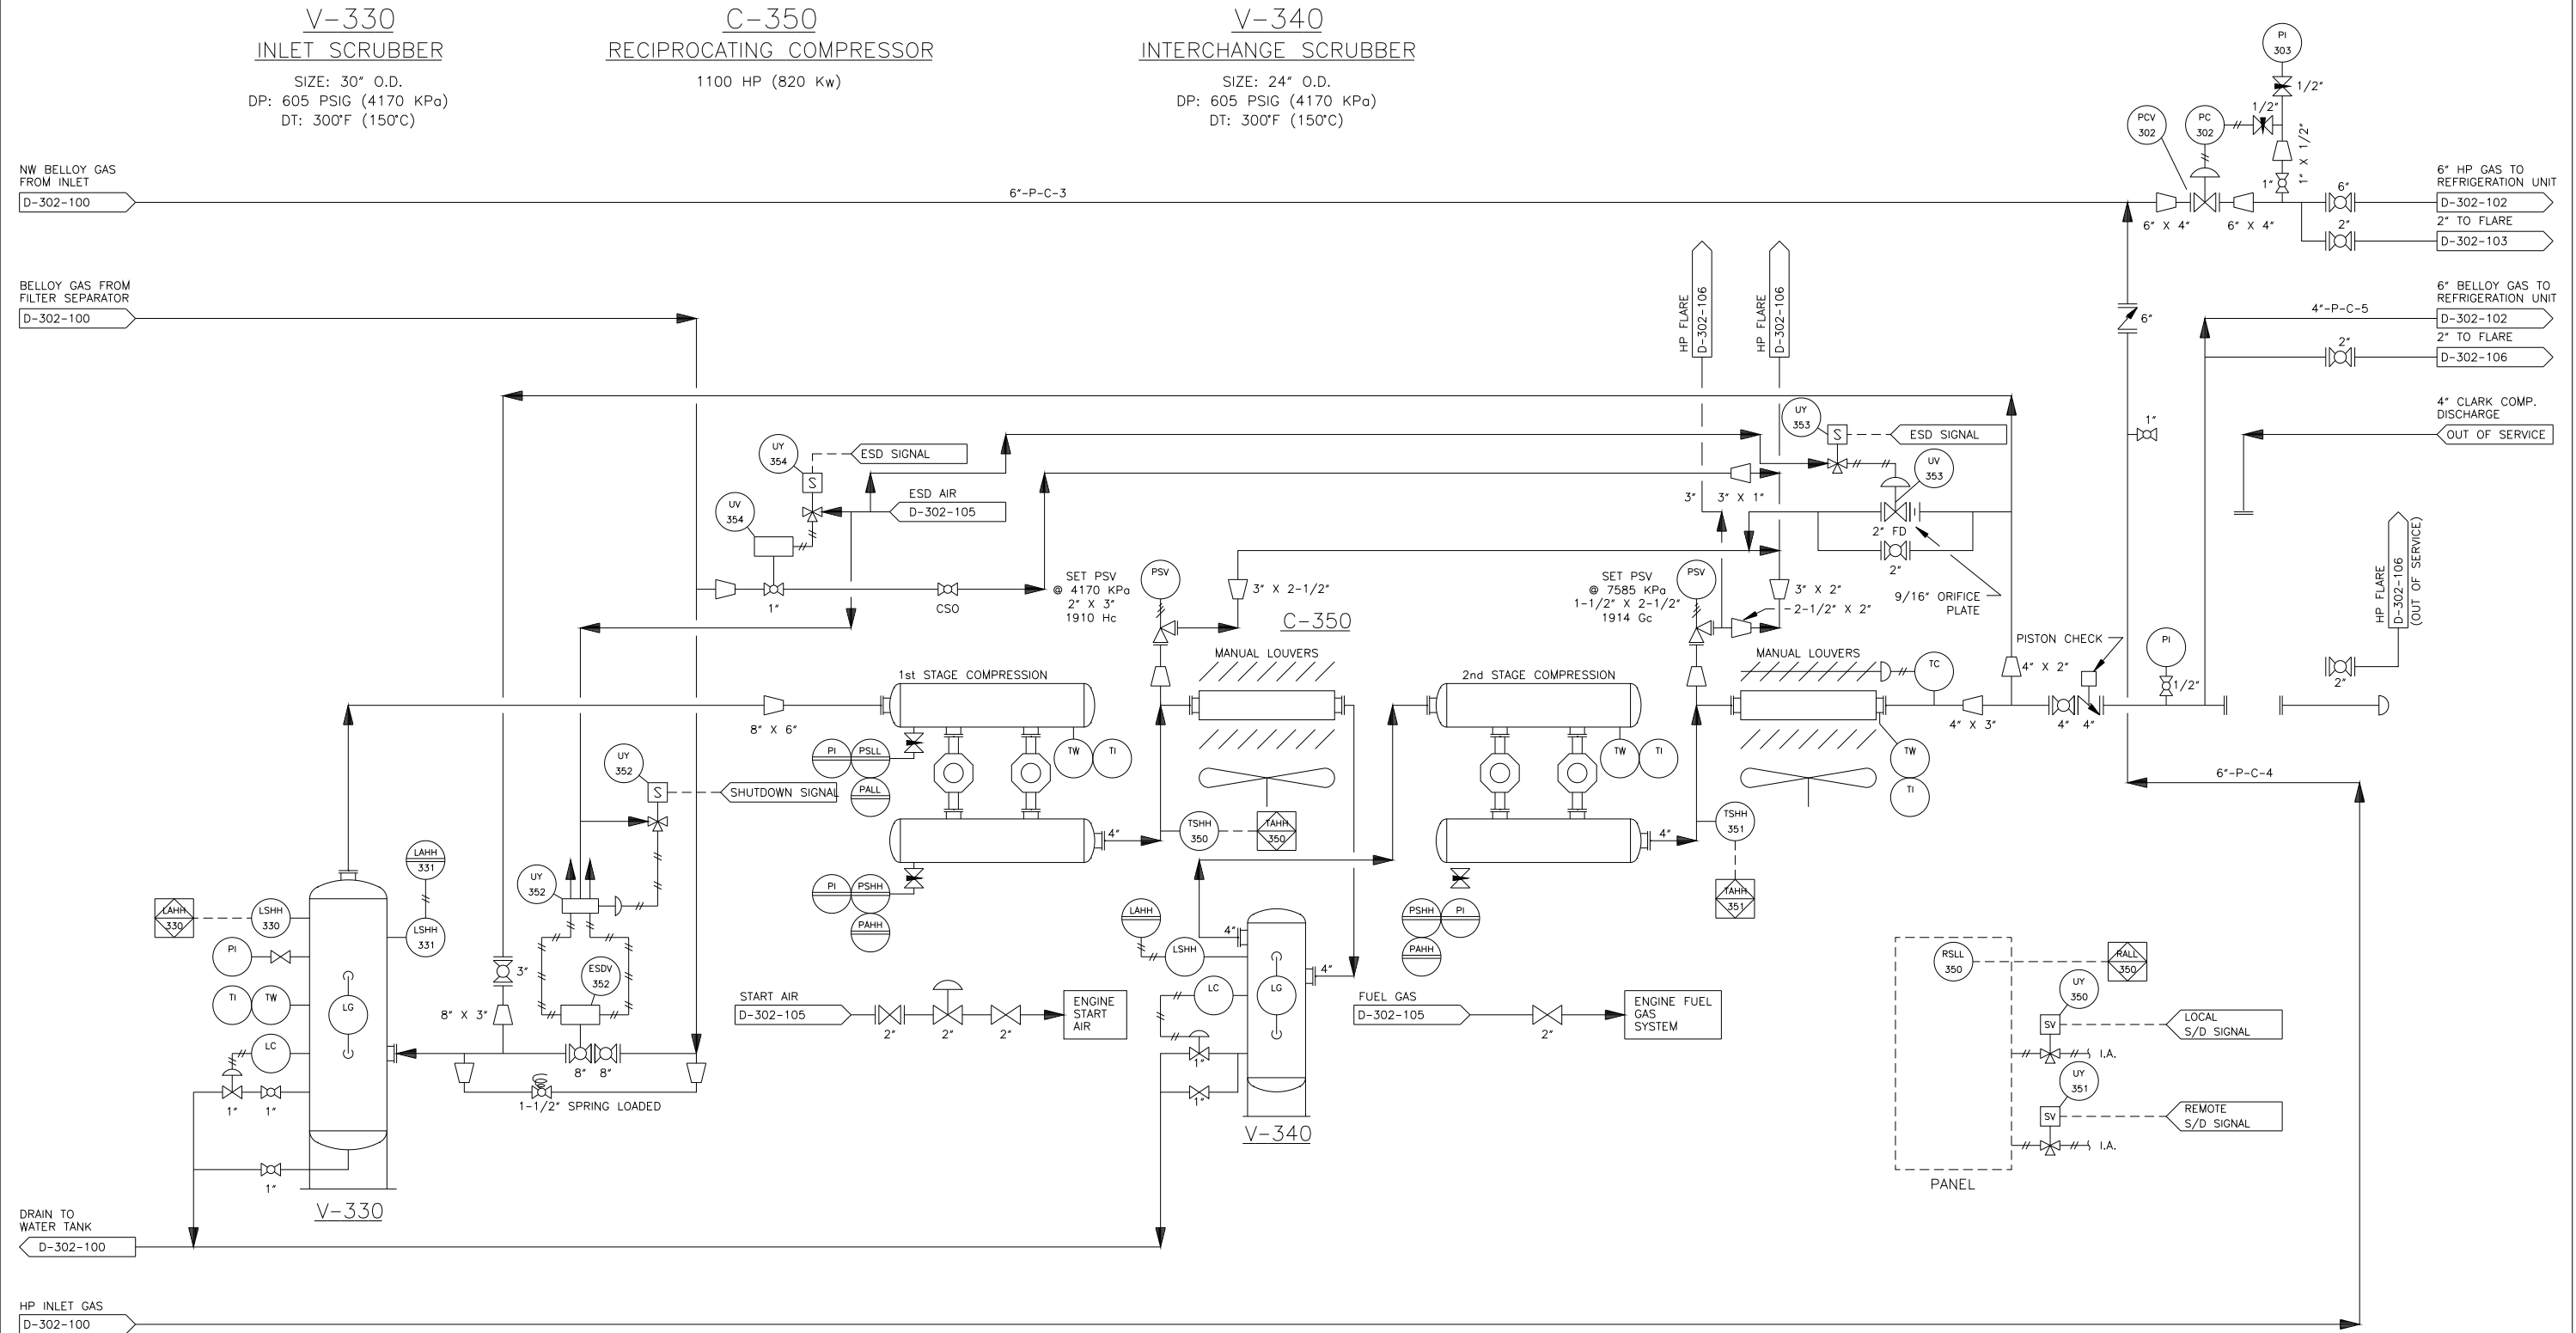

DRAWING NO.	REFERENCE DRAWINGS	REVISION	REVISION DESCRIPTION	BY	DATE	CHECKED	APPROVED	AXL	STAMPS	ENGINEERING RECORD	ANDERSON EXPLORATION LTD. CALGARY, ALBERTA, CANADA		
		1	ISSUED FOR CONSTRUCTION	WAL	22 MAY 90					DRAWN BY GDS/TDG	DATE 27 APR 90	PROJECT BELLOY GAS PLANT	
		2	REVISED ASBUILT	WAL/TDG	06 FEB 91								
		3	GENERAL REVISION	WAL	30 APR 93					CHECKED BY	DATE		
												PREPARED BY	
										ENGINEER	DATE	TITLE P&ID PROCESS COMPRESSOR	
										AXL APPROVED	DATE	SCALE NTS	DRAWING NO. D-302-101