


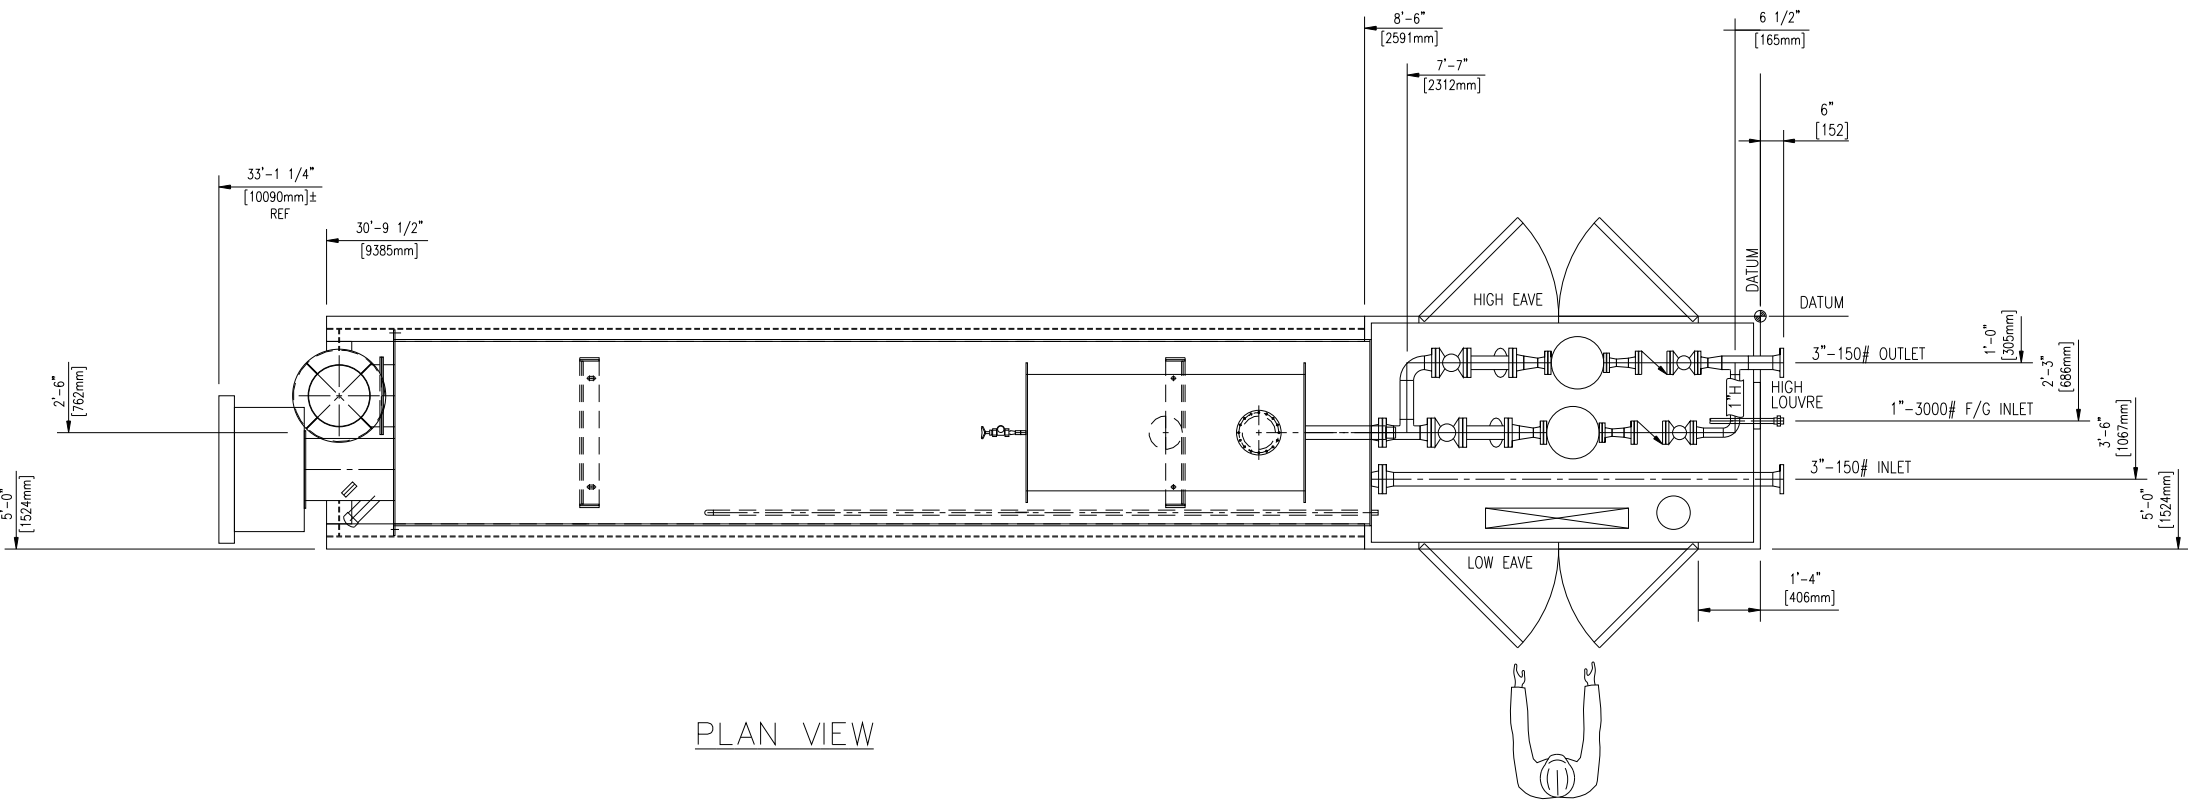


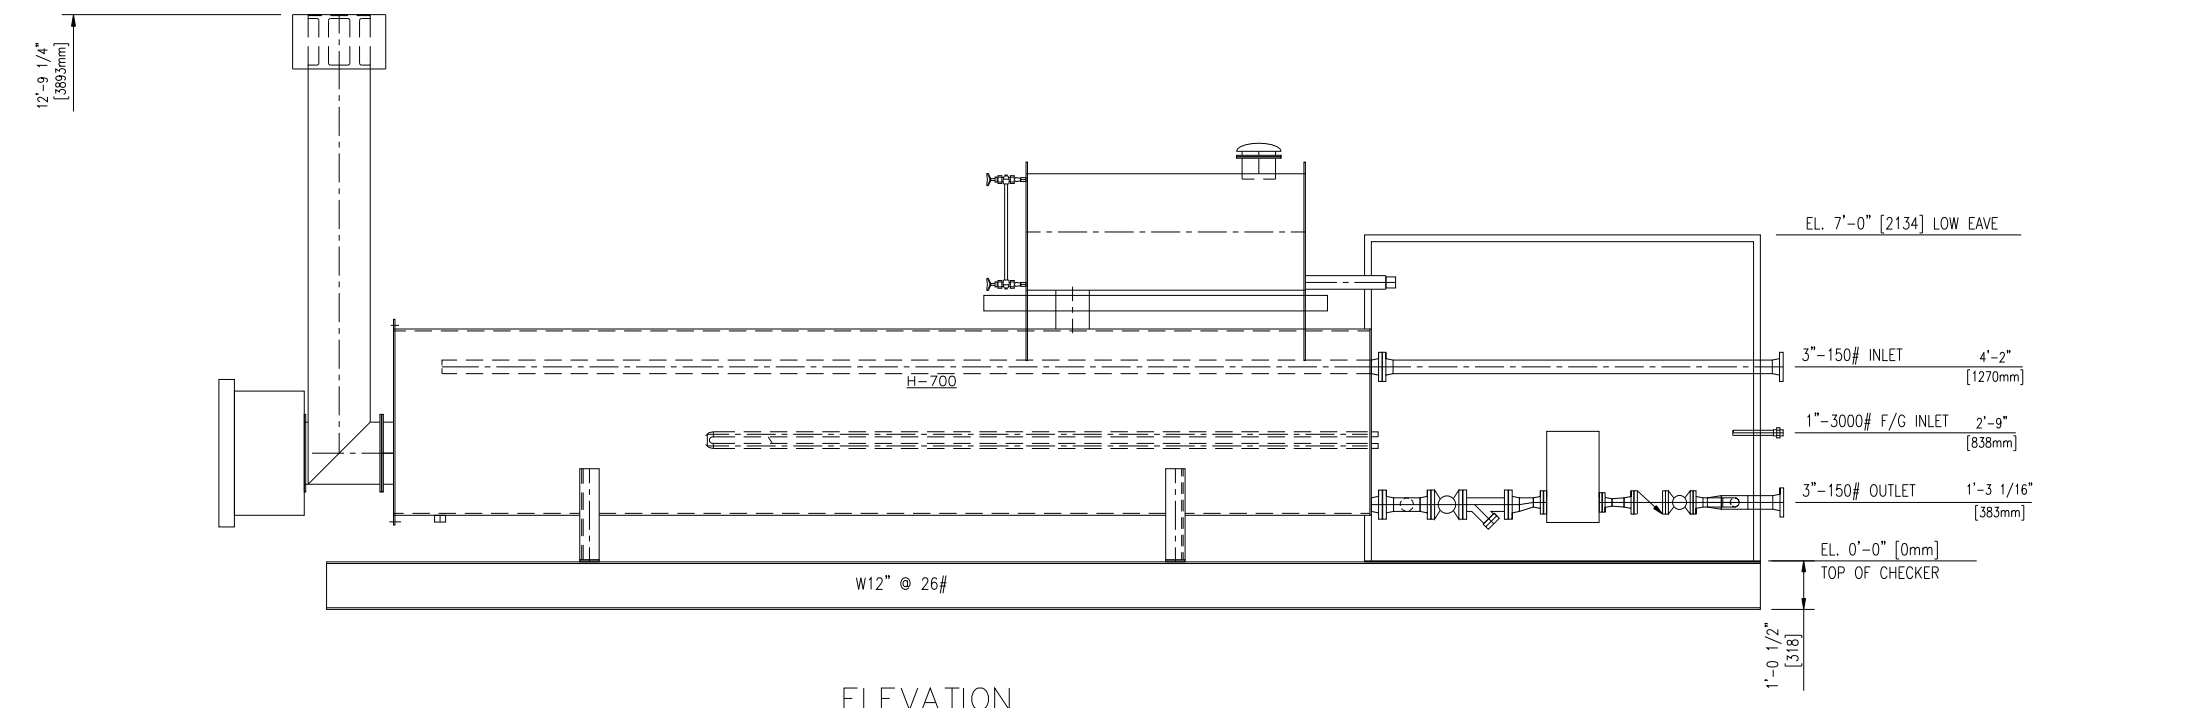

PLAN VIEW

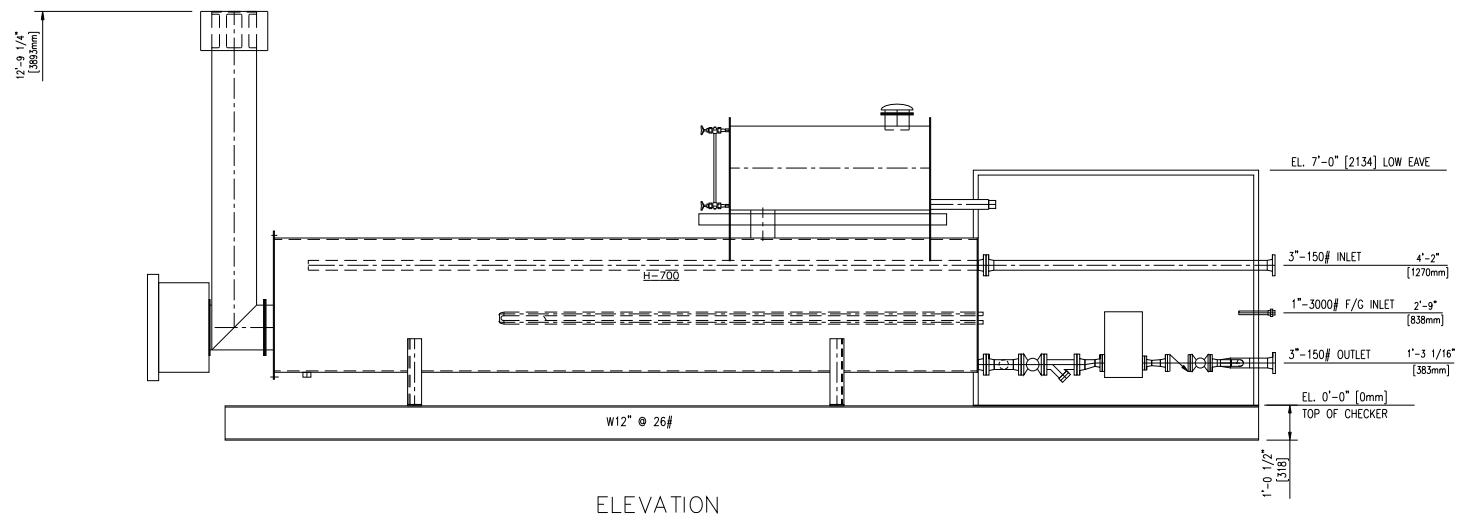

ELEVATION

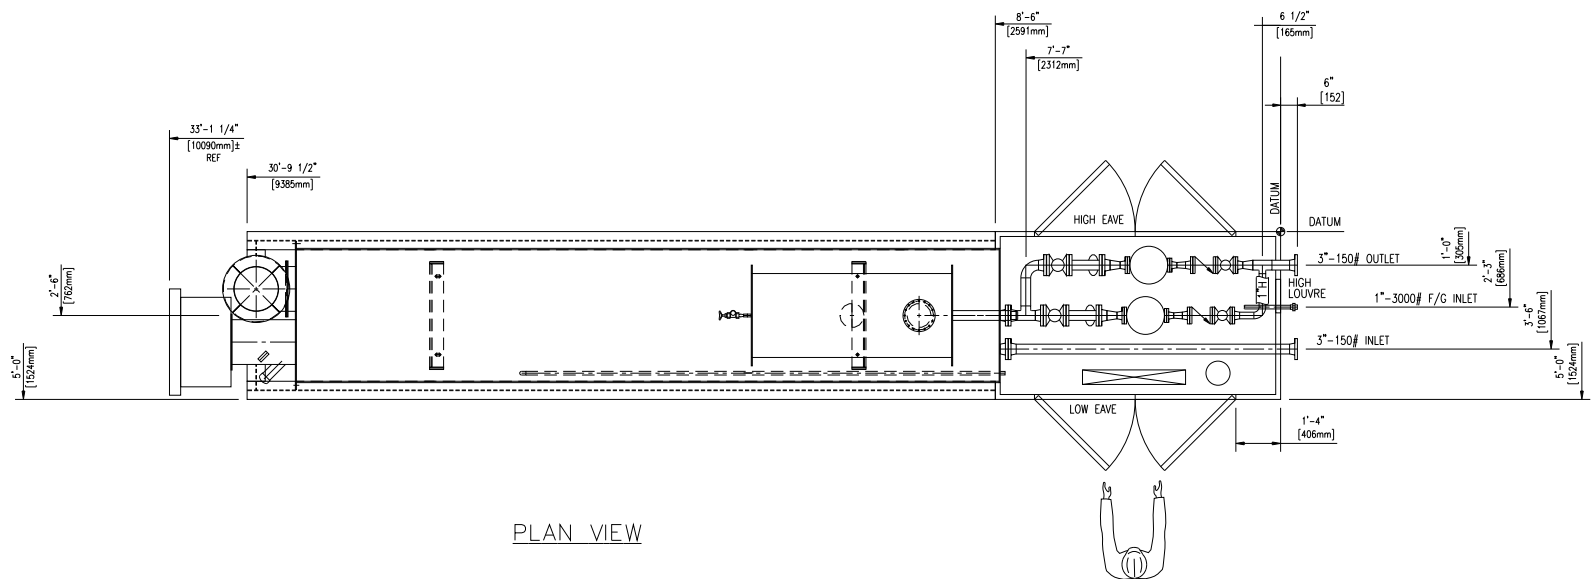

NOTES:

SKID:

- 5'-0" x 30'-9 1/2", MADE FROM W12" @ 26# BEAM
- 1/2" CHECKER PLATE FLOORING
- (4) LIFT LUGS
- 2" FOAM INSULATION

ENCLOSURE:

- 5'-0" x 8'-6" x 7'-0" EAVE, 1/12 SHED ROOF
- 24 GA. PREPAINTED STEEL SAPPHIRE BLUE EXTERIOR FOAM PANEL CONSTRUCTION
- (2) 3'-0" x 6'-0" DOORS ON EACH SIDE C/W LOCKING DROP BOLTS
- (1) 12" x 12" STAMPED ALUMINUM LOUVRE WITH SLIDING CLOSER
- (1) REMOVABLE ROOF SECTION FOR SERVICE ACCESS

PIPING:

- ALL BUTTWELD PIPING IS SCH 40
- 1 1/2" & SMALLER, NPT PIPING IS SCH 80 WITH 3000# A-105 NPT FITTINGS
- HYDRO-TESTED TO 1.5 X DESIGN PRESSURE
- 10% RADIOGRAPHY

PAINT:

- STRUCTURAL
- COMMERCIAL SANDBLAST
- (1) S/C DEVGUARD 4160 PRIMER, 2-3 MILS DFT
- (1) S/C DEVGUARD 4308 GREY ALKYD ENAMEL 2-3 MILS DFT
- INSULATED PIPING AND VESSEL
- NEAR WHITE SANDBLAST
- (1) S/C DEVTRAN 224 HS EPOXY, 6-8 MILS DFT

TUBE / TUBE FITTINGS:

- 3/8" x 0.035" WALL 316SS TUBING, S.S. SWAGelok TUBE FITTINGS WITH SS FERRULES, UNLESS NOTED OTHERWISE

INSULATION:

- 2" MINERAL WOOL W/ 0.020" SMOOTH ALUMINUM CLADDING ON HEATER SHELL
- 1" PREFORMED FIBERGLASS W/ 0.020" SMOOTH ALUMINUM CLADDING ON PIPING

(2) UNITS REQ'D

1	AS BUILT	Oct 05/04	DRL	DRL	Oct 05/04
0	ISSUED FOR APPROVAL	Aug. 03/04	DRL		
No	DESCRIPTION	DATE	DRN	APP'D	DATE

REVISIONS

MOSS FABRICATION LTD.
CALGARY mossfab@mossfabrication.com ALBERTA

TITLE
WILDHAY & CECILIA
UTILITY HEAT MEDIUM PACKAGES
PIPING PLAN & ELEVATION

SIZE	DATE	DRAWN	CLIENT: ANADARKO CANADA CORP.	
18 x 24	Aug. 03/04	DRL	TUNDRA ENGINEERING INC.	
Job. No.	SCALE	PROJ. ENG'R	DRAWING No.	REV
3544	NTS	DRL	L3544-1	1