


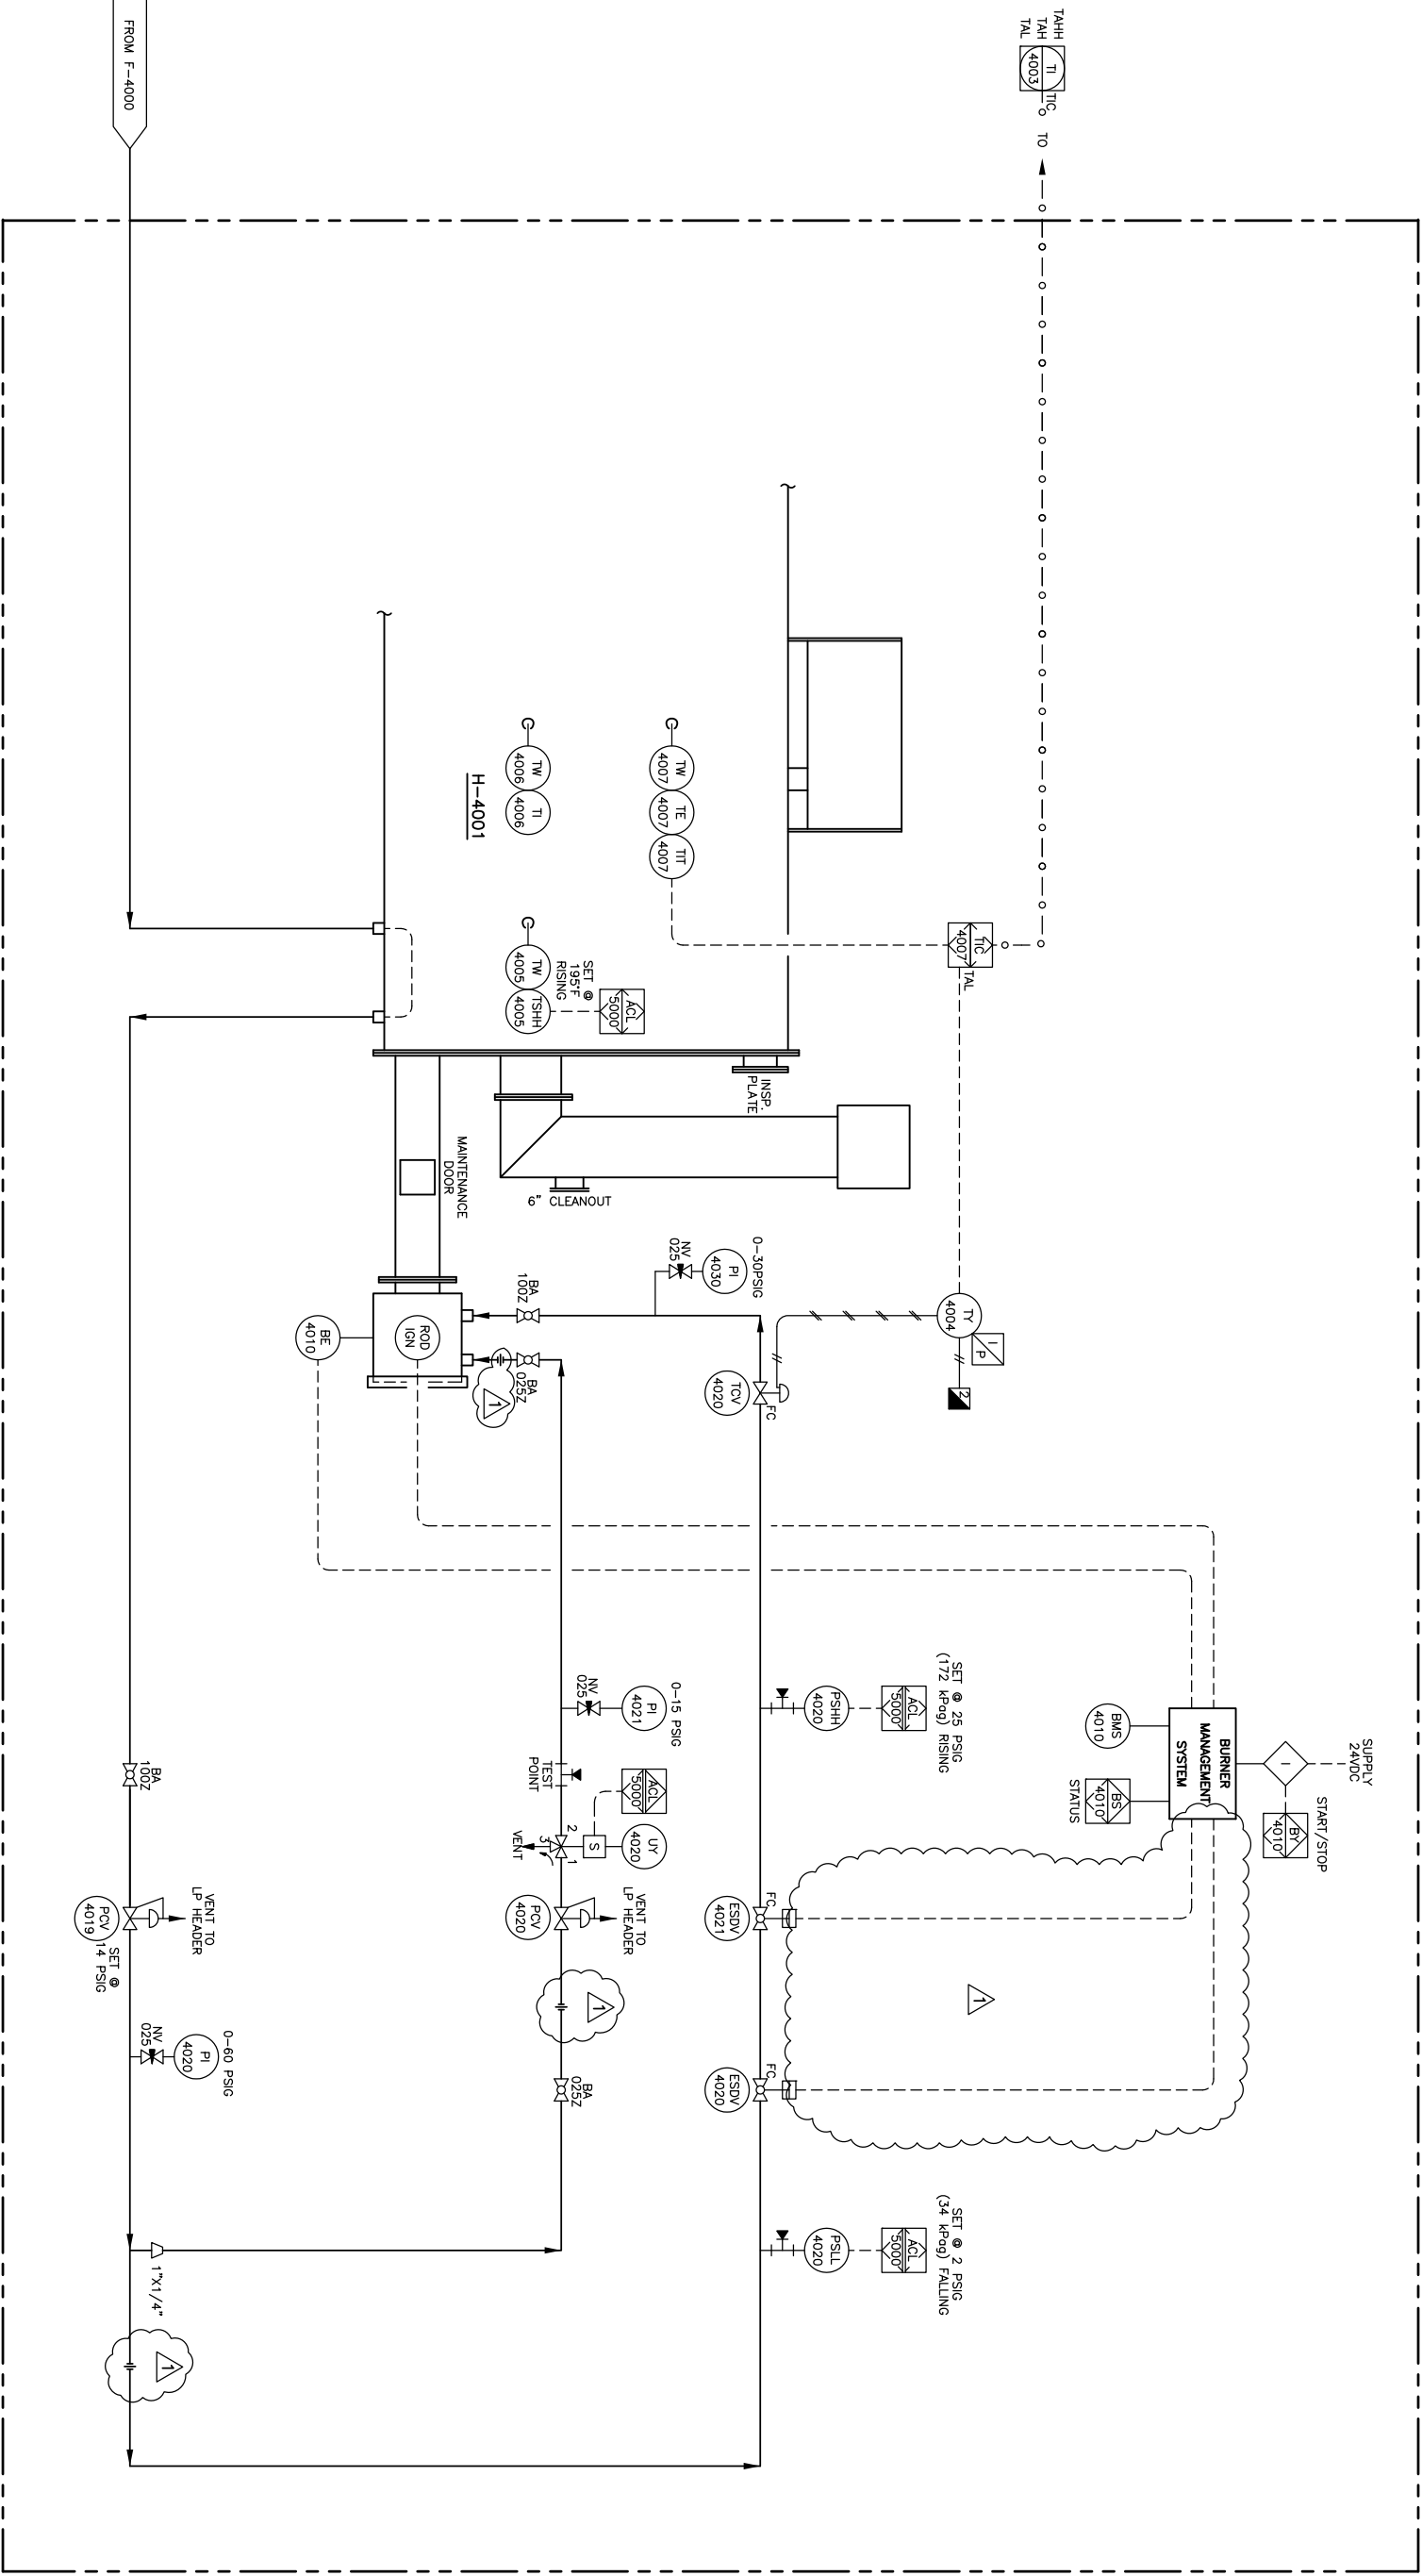

NOTES:

1) ELECTRICAL NOT IN PRESSON SCOPE OF WORK.

		CUSTOMER REFERENCE		119-22-00		CUSTOMER		BP CANADA ENERGY COMPANY c/o EQUINOX		JOB NO.		B7330-01	
						PROJECT:		TWO LAKES 3-3					
						LSD:		03-03-63-13 W6M					
						TITLE		SOUR LINE HEATER SKID PACKAGE					
						P & ID							
						DRAWN		CHECKED		APPROVED		DATE	
						M/W		M/W		M/W		06/06/13	
												ISSUANCE	
												B7330-011	
												SHT. 3 OF 3	